



CITY OF MERCED PROJECT CP210055 CANAL WATER MAIN 14TH-15TH (PG&E)

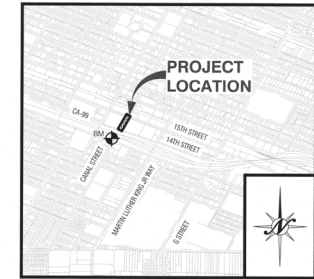

VICINITY MAP
NTS

BENCHMARK

ELEVATION 166.32
BM POLING MONUMENT SET BY CITY OF MERCED, BRASS DISC STAMPED 'CITY OF MERCED BENCHMARK DO NOT REMOVE' WITH BM-16 (POINT NUMBER) IN MONUMENT WELL. LOCATED AT THE WEST CORNER OF 15TH STREET AND CANAL STREET.

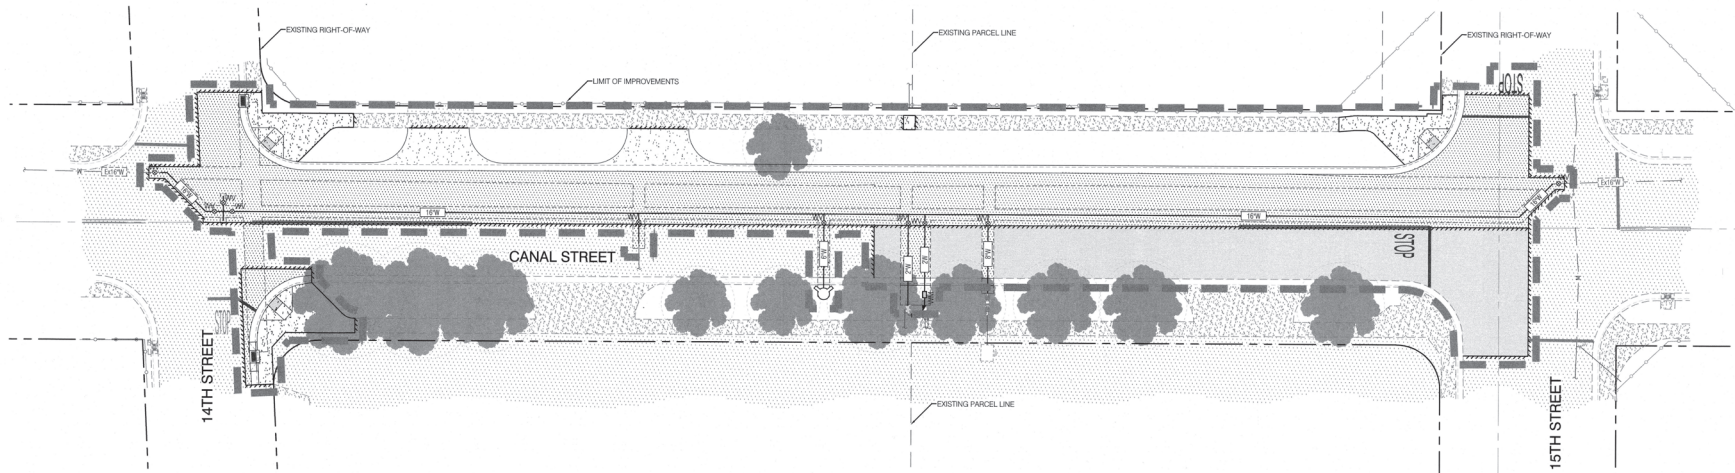

CONTACTS

A. REGULATORY AGENCY: CITY OF MERCED
1776 GORDON AVENUE
MERCED, CA 95341
T: (209) 385-6800

B. OWNER/DEVELOPER: CITY OF MERCED
1776 GORDON AVENUE
MERCED, CA 95341
T: (209) 385-6800

C. PROJECT LOCATION: CANAL STREET
MERCED, CA 95340

D. ENGINEER: NORTHSTAR ENGINEERING GROUP, INC.
820 12TH STREET
MODESTO, CA 95354
T: (209) 524-3025
F: (209) 524-3026
CONTACT: NATHAN MACHADO

APPROVALS

CITY OF MERCED
PUBLIC WORKS
ENGINEERING PROJECTS AND STANDARDS
678 W. 18TH ST., MERCED, CA 95340 (209) 385-6846

THE CITY ENGINEER FOR THE CITY OF MERCED HAS REVIEWED THE PLANS FOR CONFORMANCE WITH THE CITY REQUIREMENTS ONLY. SINCE PLANS WERE PREPARED BY OTHERS, NO RESPONSIBILITY FOR THE ACCURACY OF THE DESIGN IS EXPRESSED.

Michael J. Waples 11/20/23
MICHAEL J. WAPLES, P.E. INTERNAL CITY ENGINEER DATE

Johnnie Baptista 11/29/23
JOHNNIE BAPTISTA, PROJECT CHAMPION DATE

KEN ELWIN, P.E., PUBLIC WORKS DIRECTOR DATE

SHEET INDEX

GENERAL INFORMATION

- C1.1 COVER SHEET
- C1.2 LEGEND AND ABBREVIATIONS
- C1.3 GENERAL NOTES AND SPECIFICATIONS
- C1.4 DETAILS AND CROSS SECTIONS
- C1.5 DETAILS AND CROSS SECTIONS
- C1.6 DETAILS AND CROSS SECTIONS

SITE PLANS

- C2.1 TOPOGRAPHIC AND DEMOLITION PLAN
- C2.2 TOPOGRAPHIC AND DEMOLITION PLAN
- C3.1 DIMENSION, PAVING, AND STRIPING PLAN
- C4.1 CANAL STREET (STA. 9+50.00 TO 12+00.00) PLAN AND PROFILES
- C4.2 CANAL STREET (STA. 12+00.00 TO 13+75.00)
- C4.3 CANAL STREET (STA. 13+75.00 TO 15+30.00)
- C5.1 EROSION CONTROL PLAN, NOTES, AND DETAILS
- C5.2 EROSION CONTROL PLAN, NOTES, AND DETAILS
- C6.1 UTILITY POT-HOLING PLAN
- C6.2 UTILITY POT-HOLING PLAN



NO.	DATE	APPROVED	DESCRIPTIONS

COVER SHEET
CITY OF MERCED PROJECT CP210055
CANAL WATER MAIN 14TH-15TH (PG&E)
MERCED, CALIFORNIA

Northstar
Engineering Group, Inc.
820 12TH STREET
MODESTO, CA 95354
(209) 524-3025 Phone (209) 524-3026 Fax

JOB # 23-0377
DATE 11/20/23
SCALE AS SHOWN
DRAWN BY
DESIGN BY
CHECKED BY

SHEET
NUMBER

C1.1